

C		Doc. Date:	13/09/2013	Project:	SZCZECIN2	Document code:	GMV 22915/13 V8/13	Scheme type:	Connections	Page number	1
B		Drawn:	AASM			Internal Code:	GMV-S22-INST-33			Number of pages:	10
A	V8	Approved:	BBHH								
	Page Version	Page Date	Authorized	RCMP							




Installation
General Diagram




Customer:
ZDiTM SZCZECIN

INSTALACJA ELEKTRYCZNA PO STRONIE POJAZDU

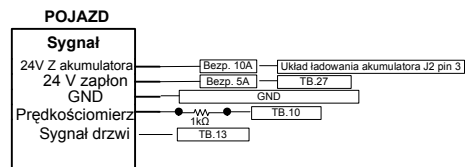


KASOWNIKI

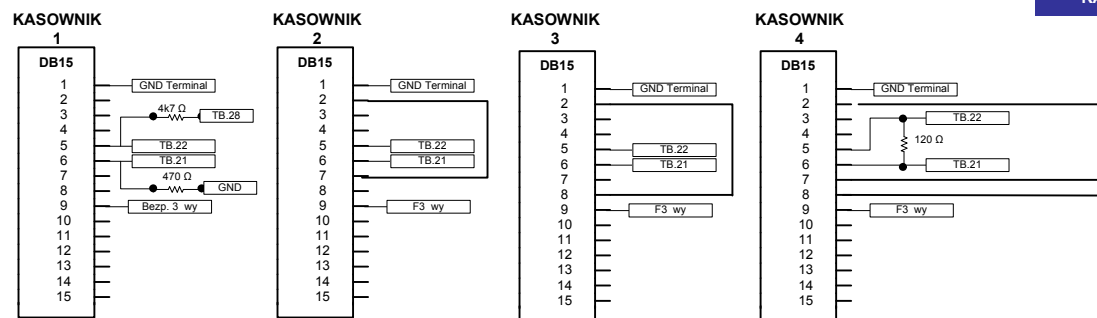

INTERFEJS KIEROWCY

 INTERFEJS KIEROWCY




M20



VGA

Kabel VGA Męski/żeński

 INTERFEJS KIEROWCY



INTERFEJS KIEROWCY



Jack żeński

Jack męski


Przewód 1mm
czerwony

Przewód 1mm
czarny


F4

GND


KONWERTER 24/12V DC

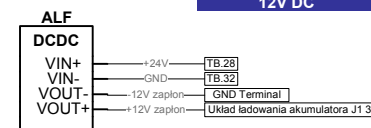









ANTENY

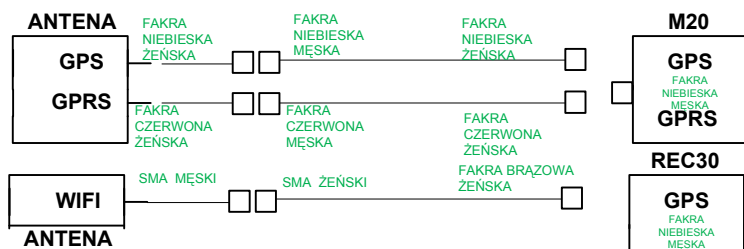


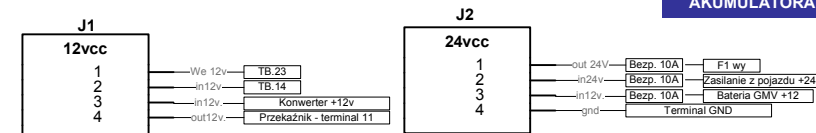

UKŁAD ŁADOWANIA AKUMULATORA

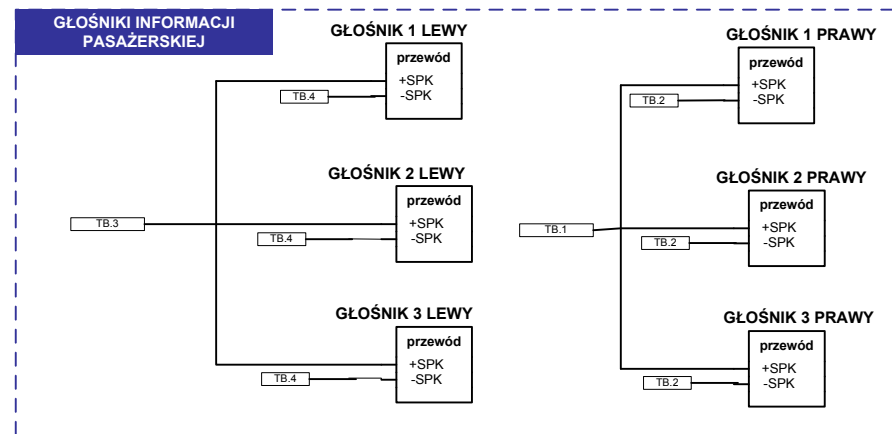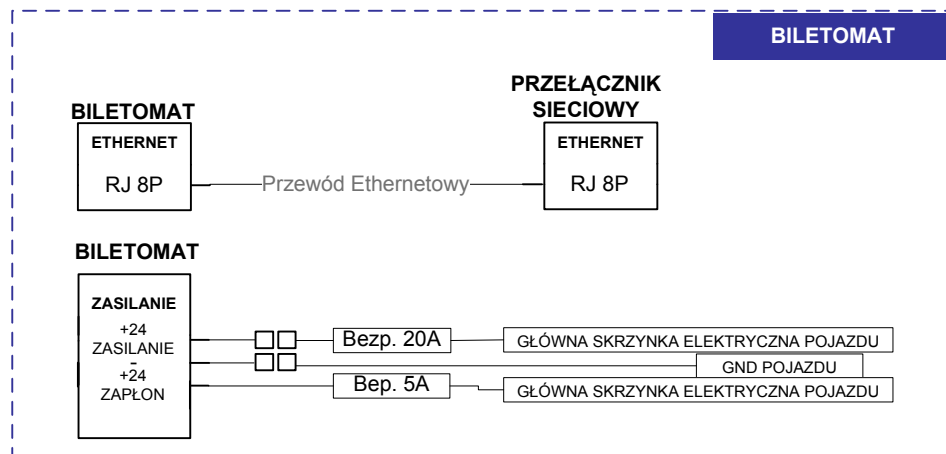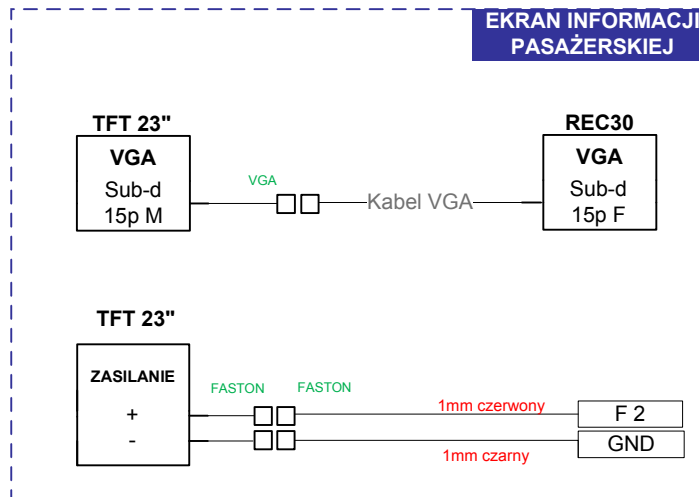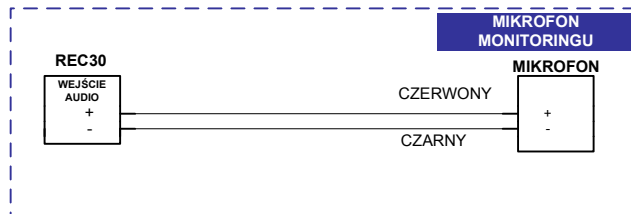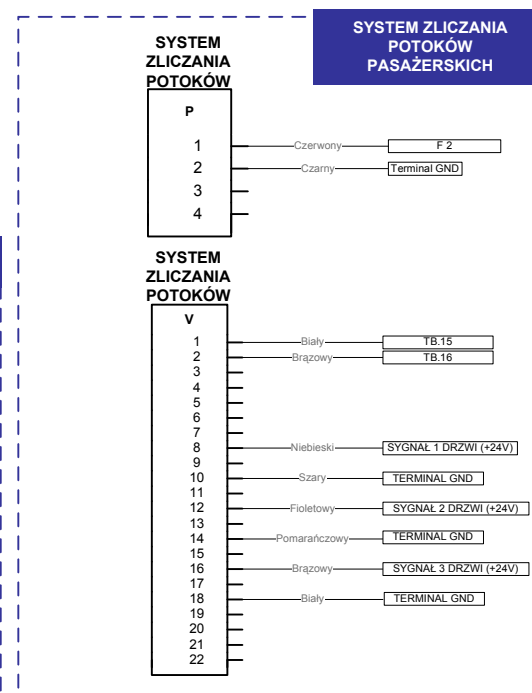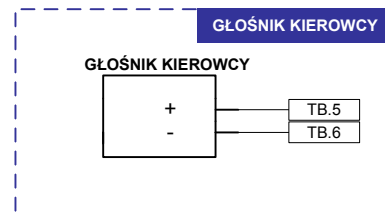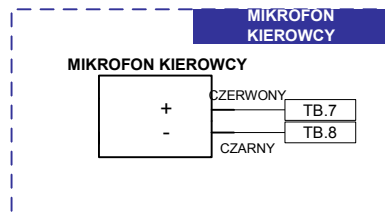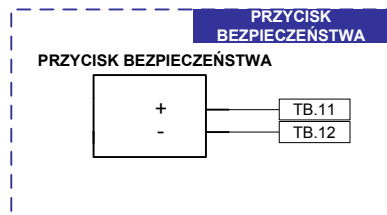


C		Doc. Date:	13/09/2013	Project:	SZCZECIN2	Title:	Installation General Diagram	Document code: GMV 22915/13 V8/13	Schema type: Connections	Page number	3
B		Drawed:	AASM					Internal Code: GMV-SZ2-INST-33		Number of pages:	10
A	V8	Approved:	BBHH					Customer: ZDITM SZCZECIN			
	Page Version	Page Date	Authorized	RCMP							

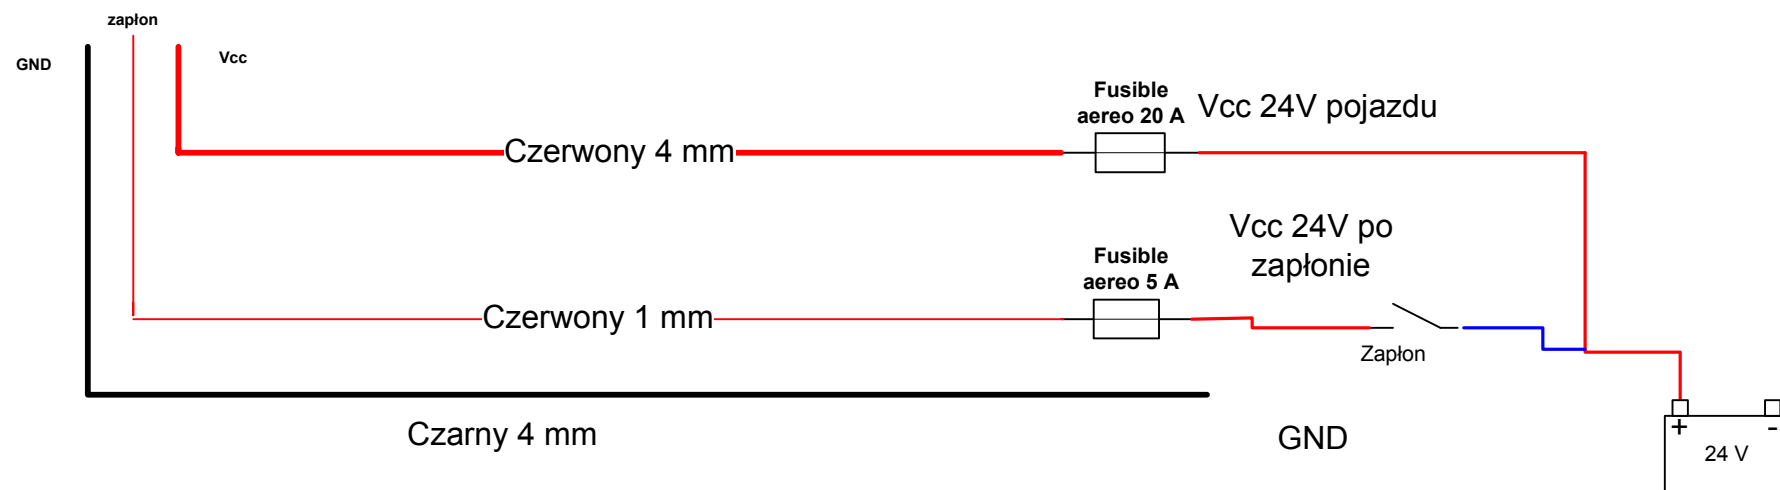




C			Doc. Date:	02/04/2014	Project: SZCZECIN 2		Title: Installation General Diagram TRB	Document code: GMV23263/14 V1/14		Scheme type:		
B			Drawed:	AASM				Internal Code:		Connections		
A	V1		Approved	IIMH					Customer:		Page number	5
	Page Version	Page Date	Authorized	BBHH					ZdTM SZCZECIN		Number of pages:	

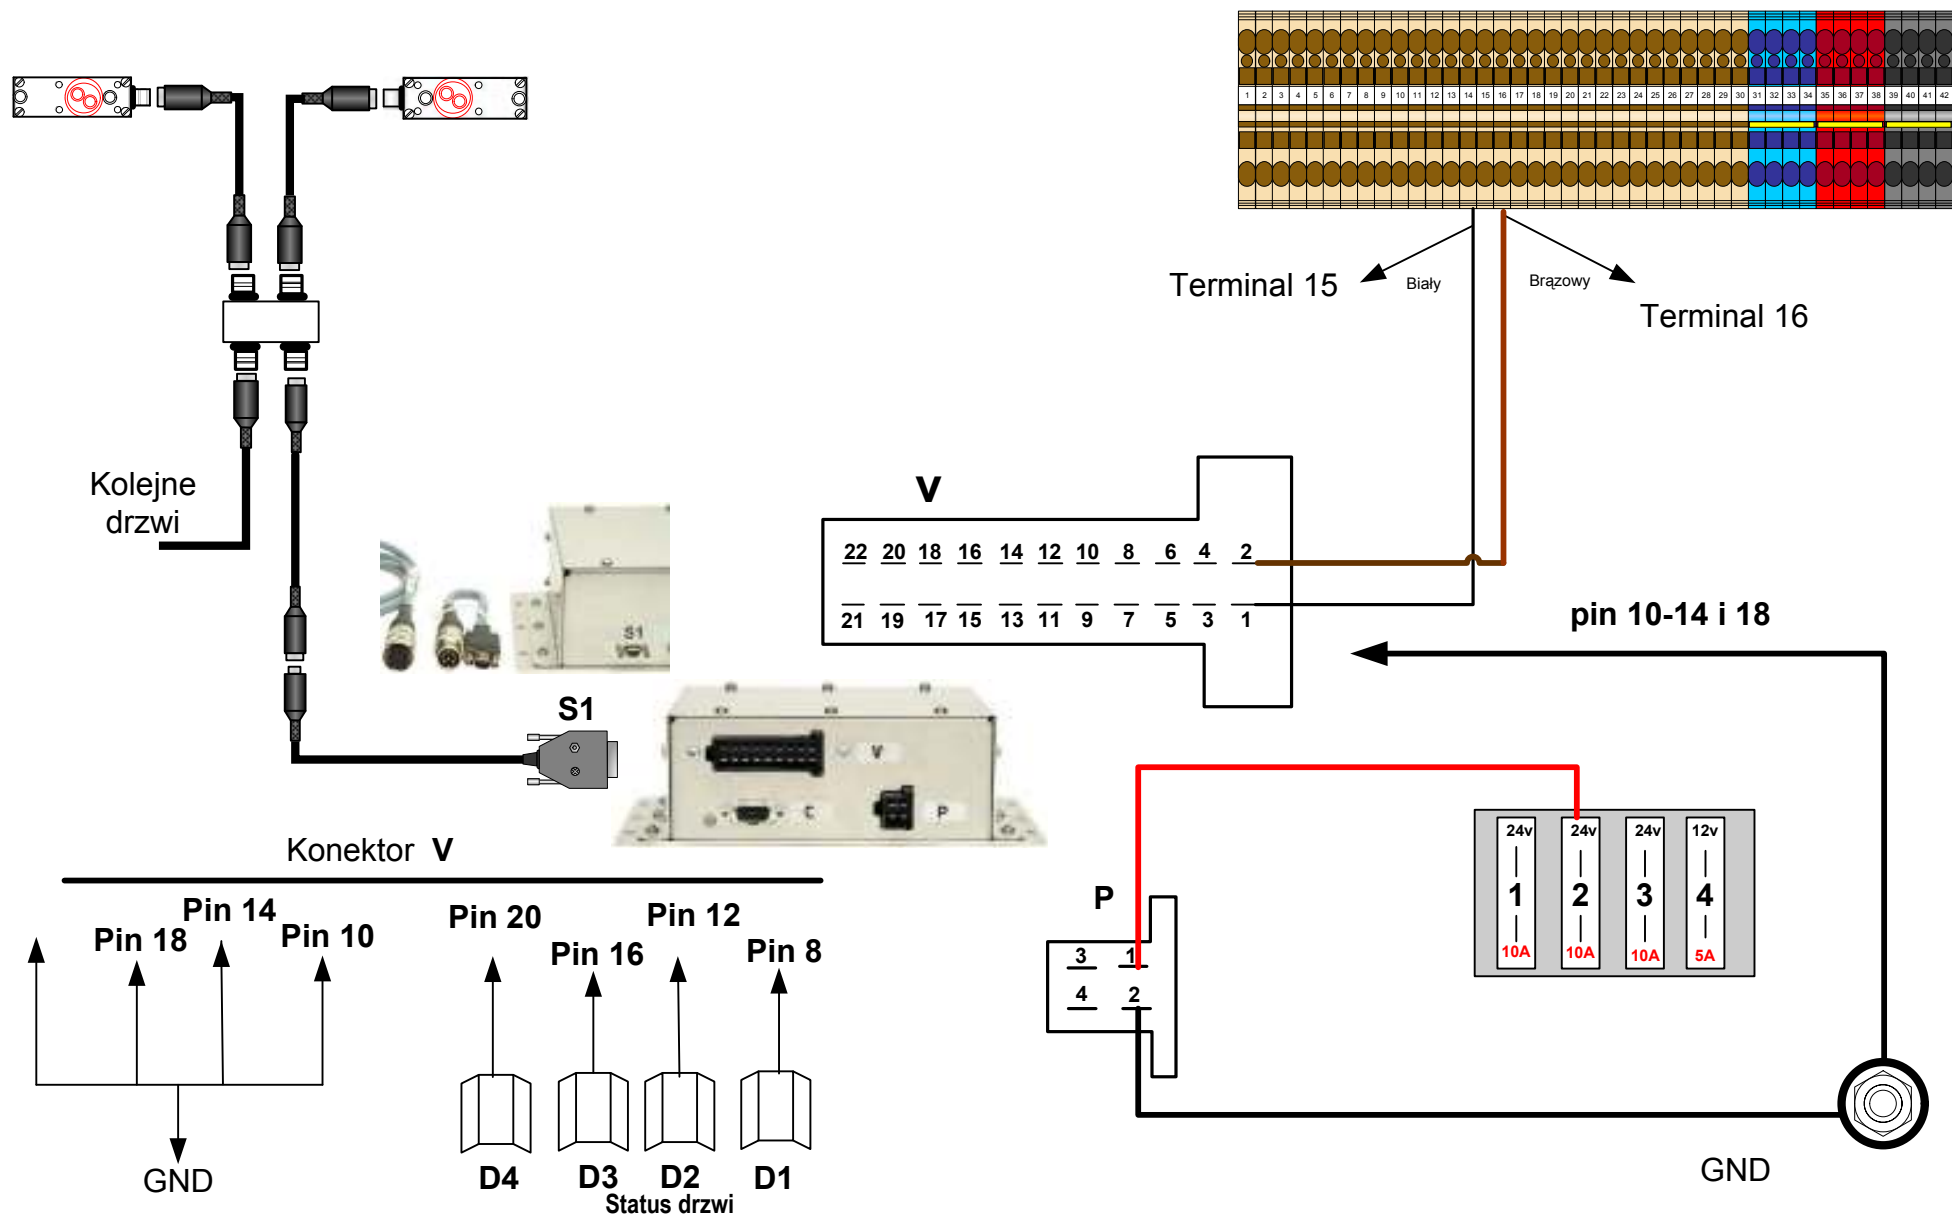


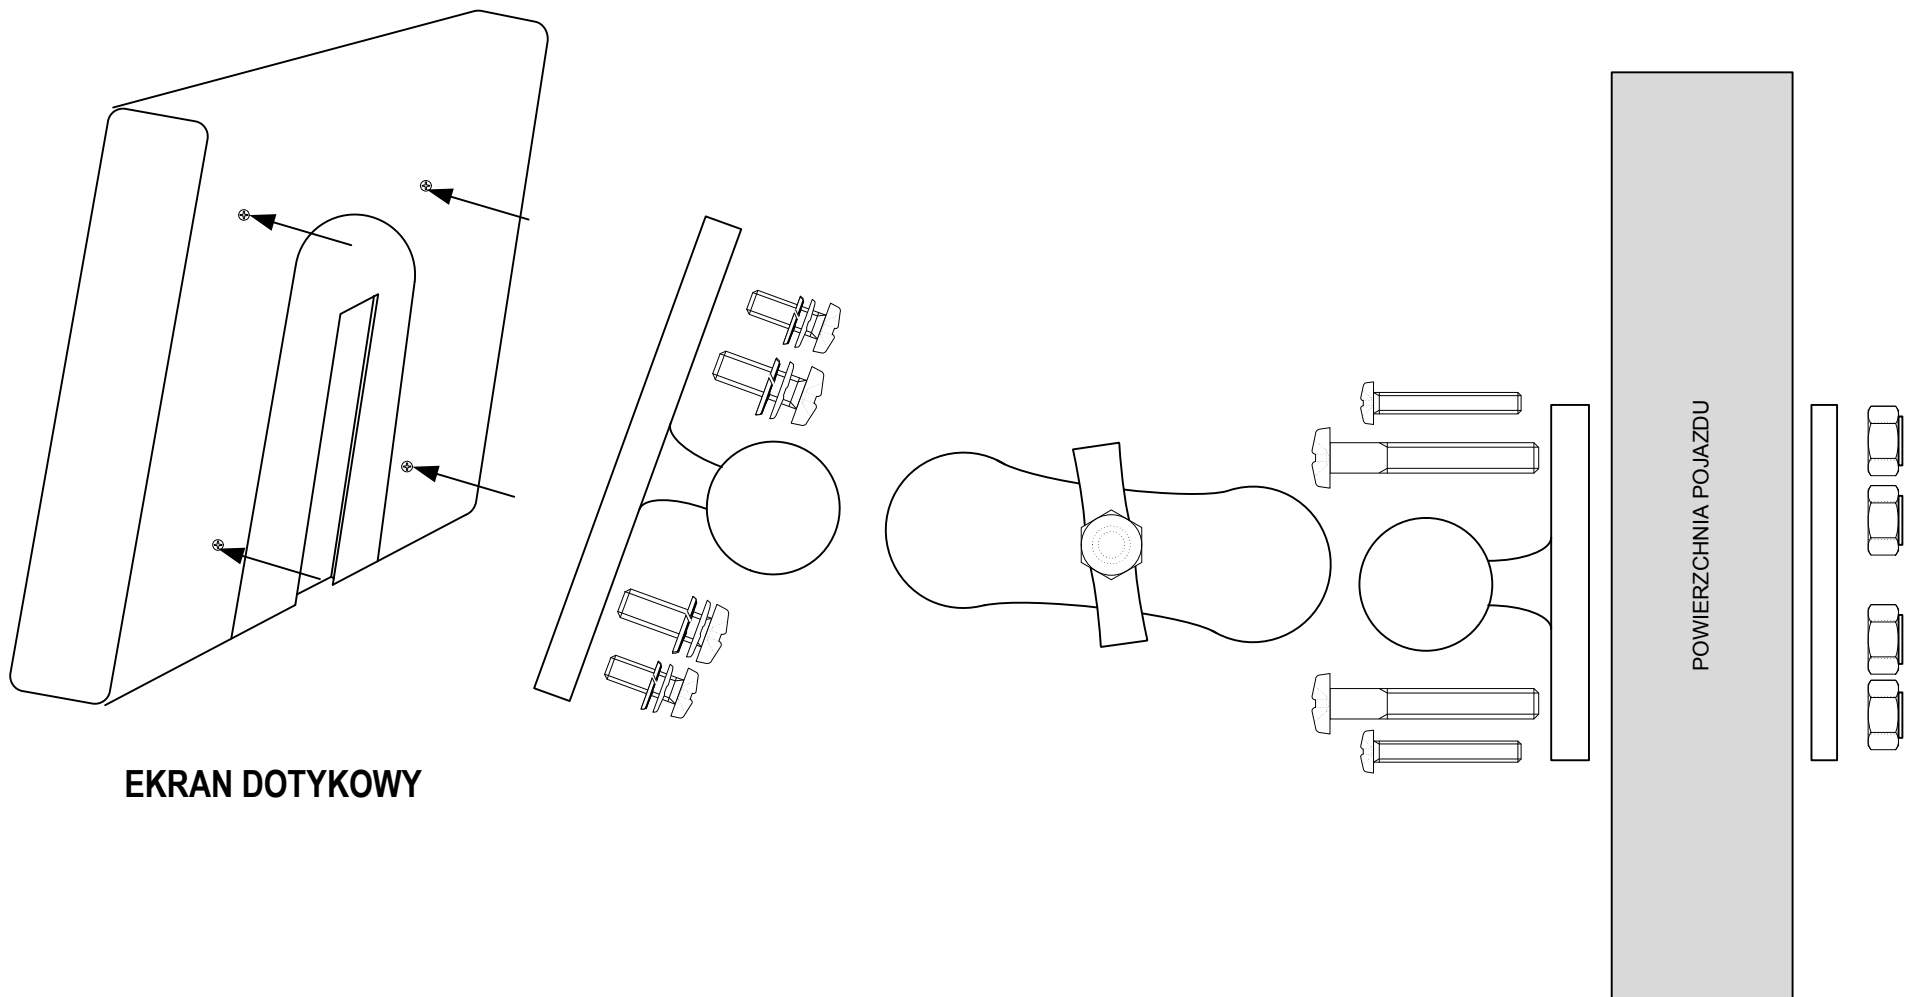

C		Doc. Date:	13/09/2013	Project:	SZCZECIN2	Document code:	GMV 22915/13 V8/13	Scheme type:	Connections	Page number	6
B		Drawed:	AASM			Internal Code:	GMV-SZ2-INST-33			Number of pages:	10
A	V8	Approved:	BBHH			Customer:	ZDITM SZCZECIN				
	Page Version	Page Date	Authorized	RCMP							




EKRAN DOTYKOWY

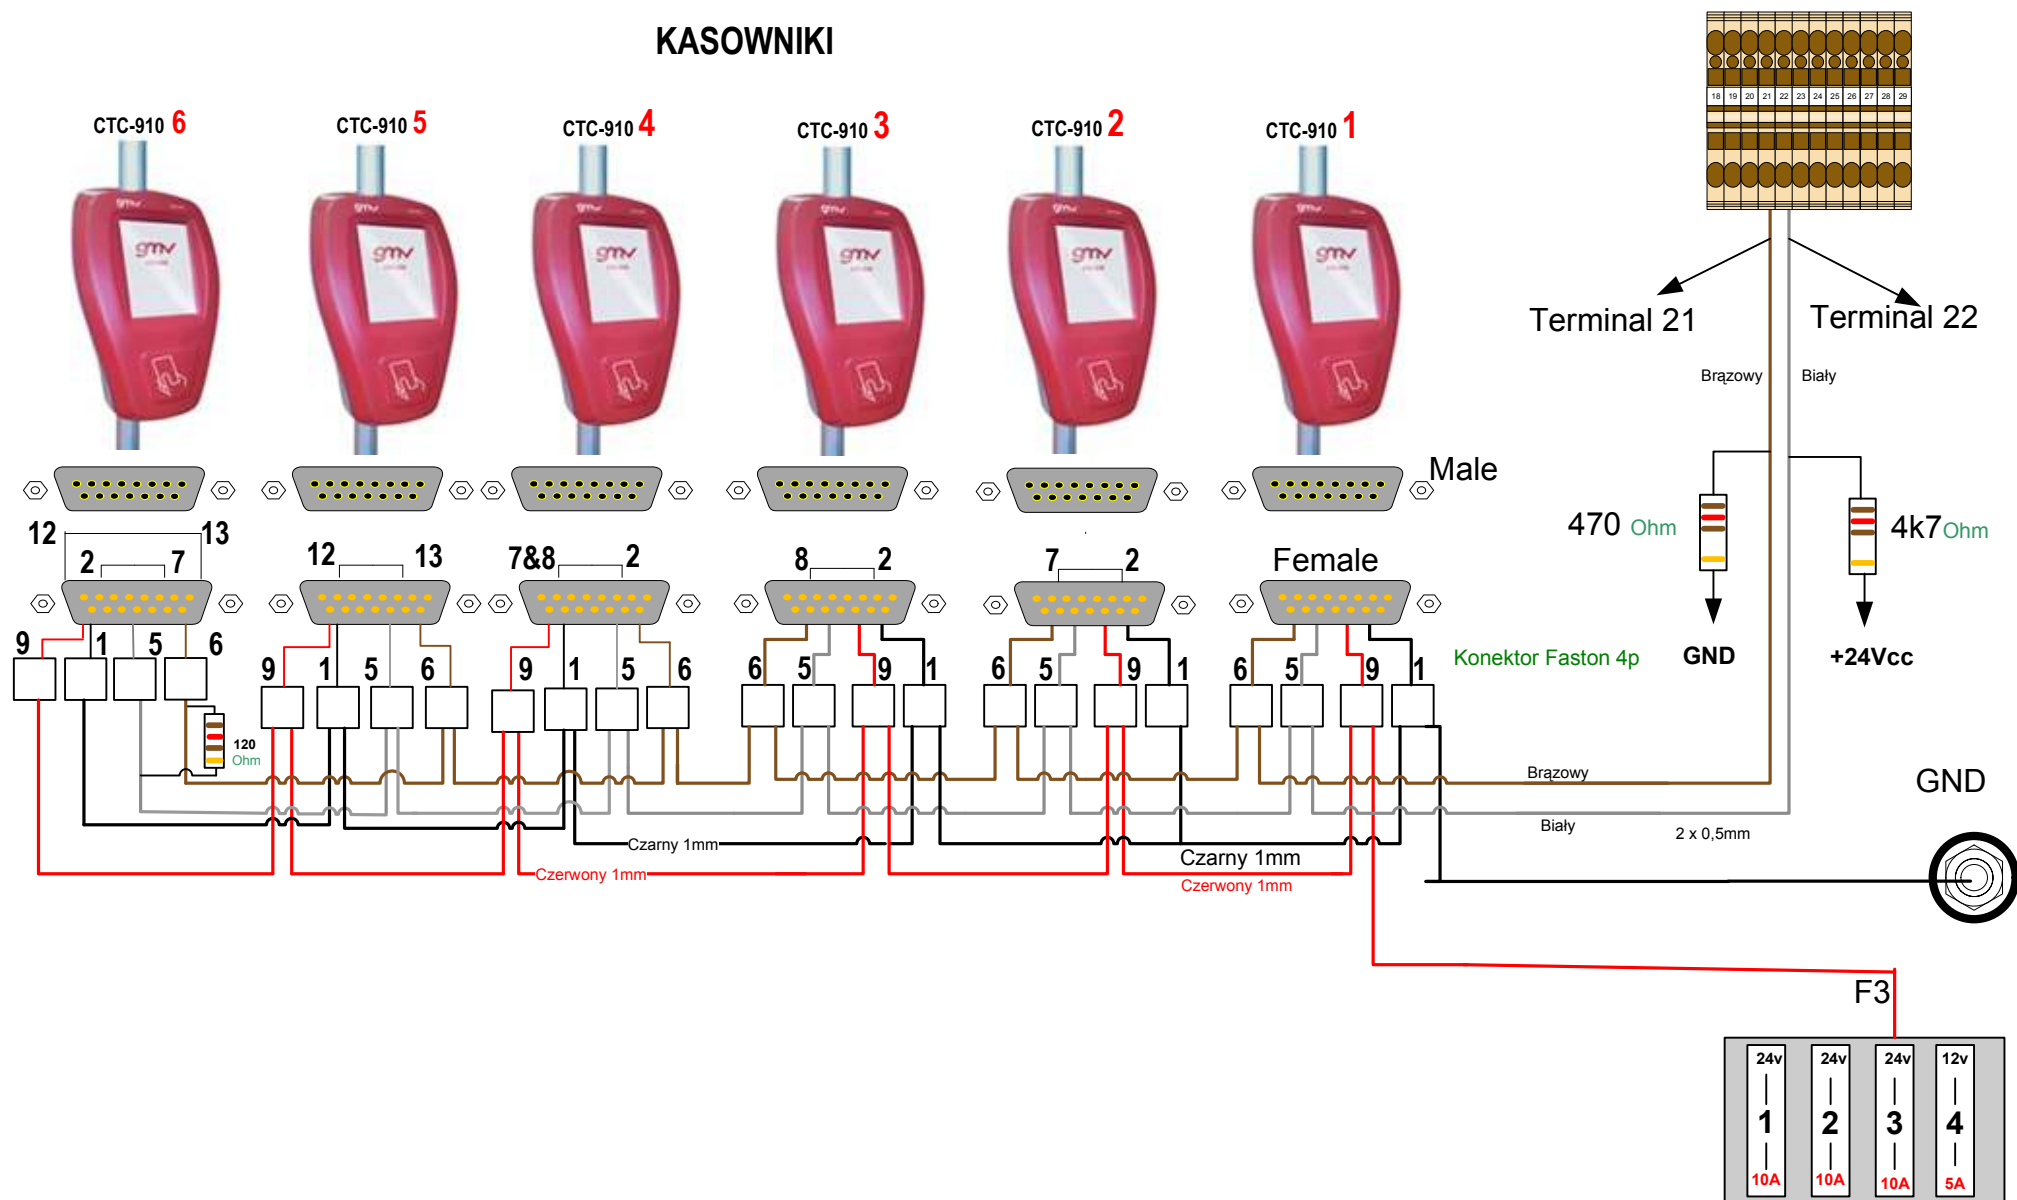
KASOWNIKI




C			Doc. Date:	02/12/2013	Project: SZCZECIN 2		Title: Installation General Diagram CTC	Document code: GMV23263/13 V3/13		Scheme type:		
B			Drawed:	AASM				Internal Code:		Connections		
A	V1		Approved	IIMH					Customer:		Page number	8
	Page Version	Page Date	Authorized	BBHH					ZdITM SZCZECIN		Number of pages:	10

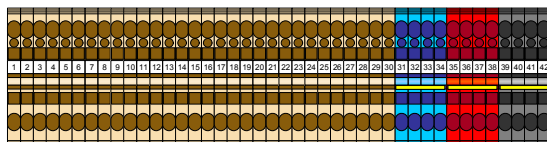

Listwa terminali

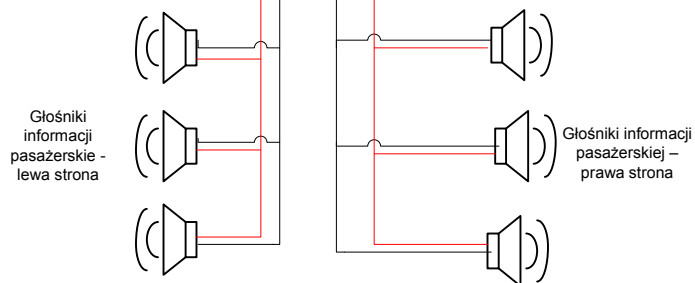

OPIS PODŁĄCZENIA							
Konektor			Terminal	OPIS	URZĄDZENIA		
Urządzenie	Złącze	PIN			PIN	KONEKTOR	EQUIPO
MINI20	MEGAF	2A	1	Wyjście audio+			Głośniki - strona prawa
MINI20	MEGAF	2B	2	Wyjście audio			Głośniki - strona prawa
MINI20	MEGAF	1A	3	Wyjście audio+			Głośniki - strona lewa
MINI20	MEGAF	1B	4	Wyjście audio			Głośniki - strona lewa

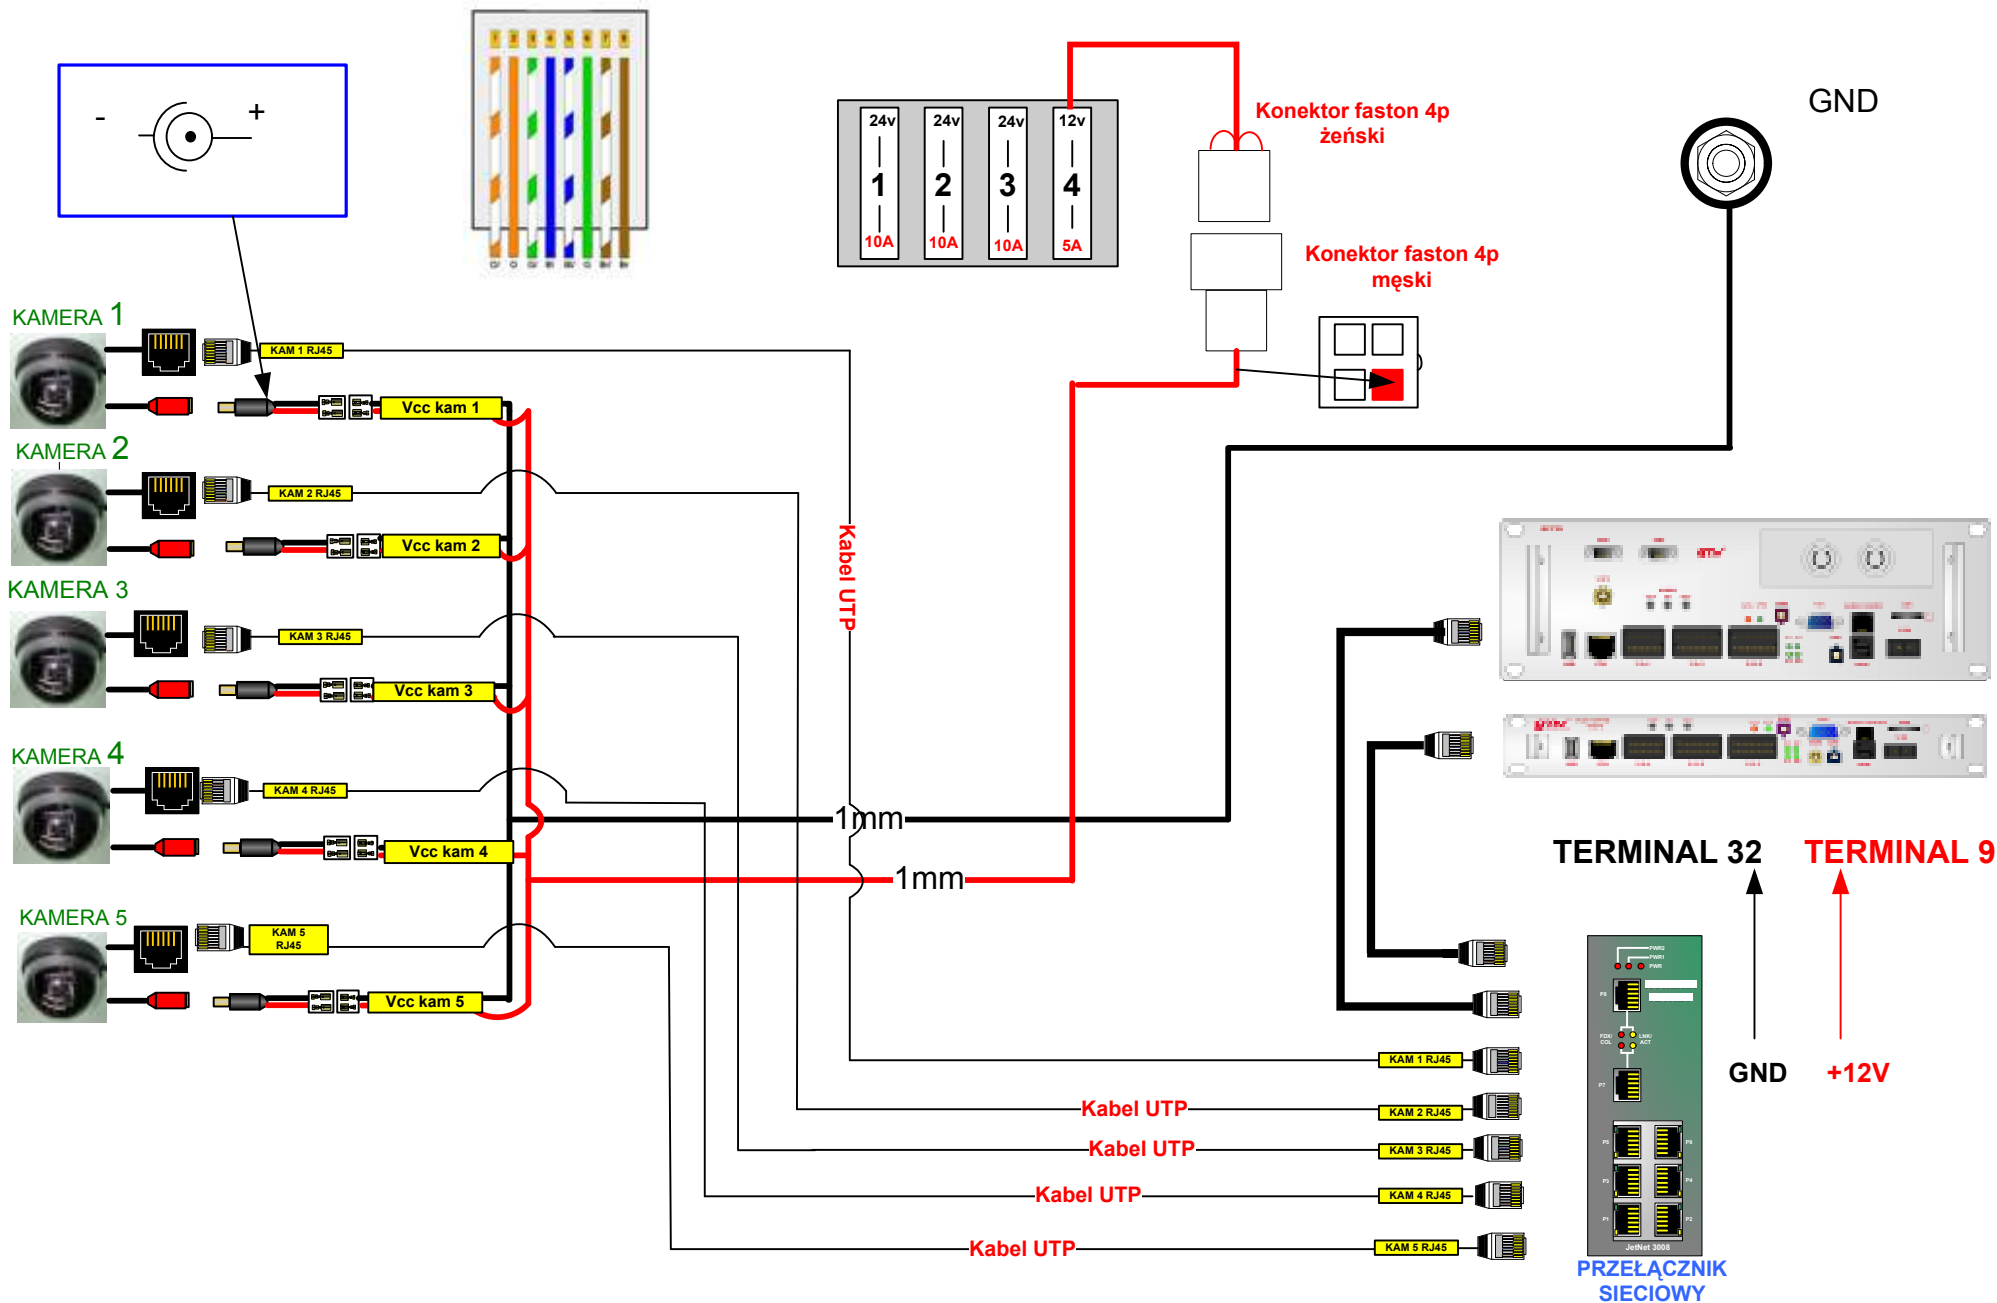

C		Doc. Date:	02/12/2013	Project:	SZCZECIN 2	Document code:	GMV23263/13 V4/13	Scheme type:	Connections	Page number	10
B		Drawn:	AASM			Internal Code:				Number of pages:	10
A	V1	Approved:	IIMH								
	Page Version	Page Date	Authorized	BBHH							



Title:
Installation
General Diagram Digital Cameras



Customer:
ZDITM SZCZECIN