

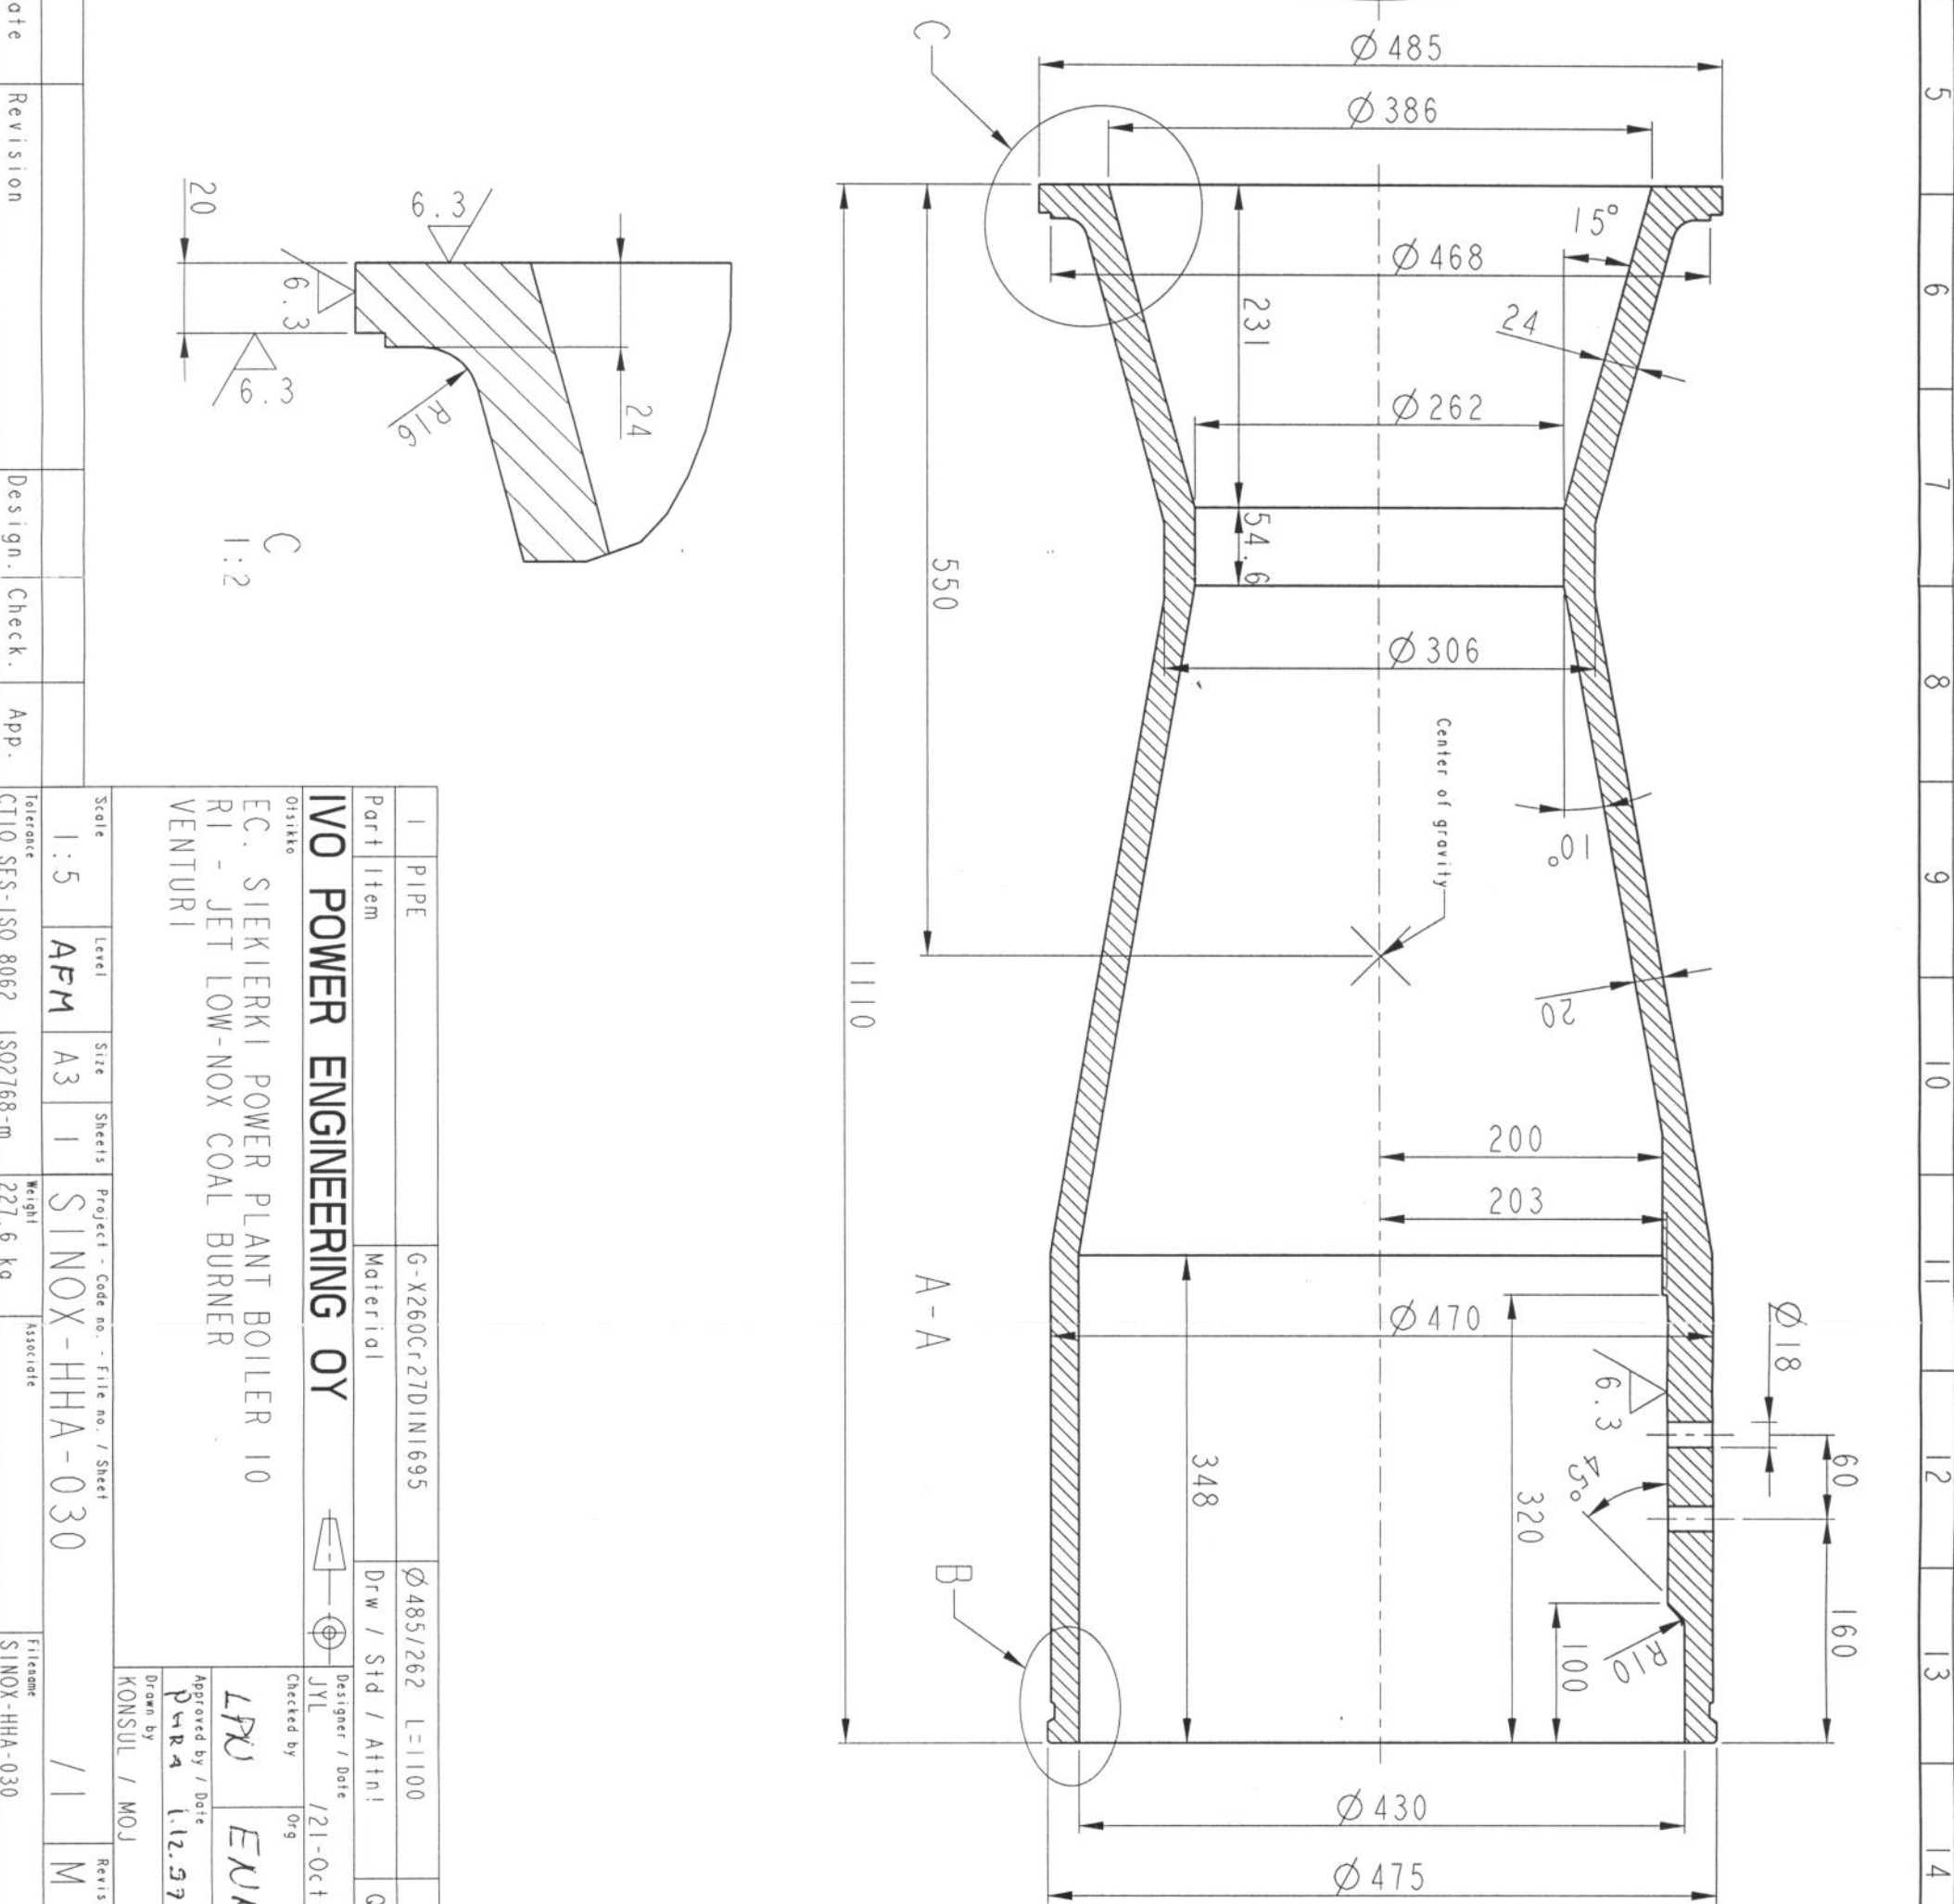
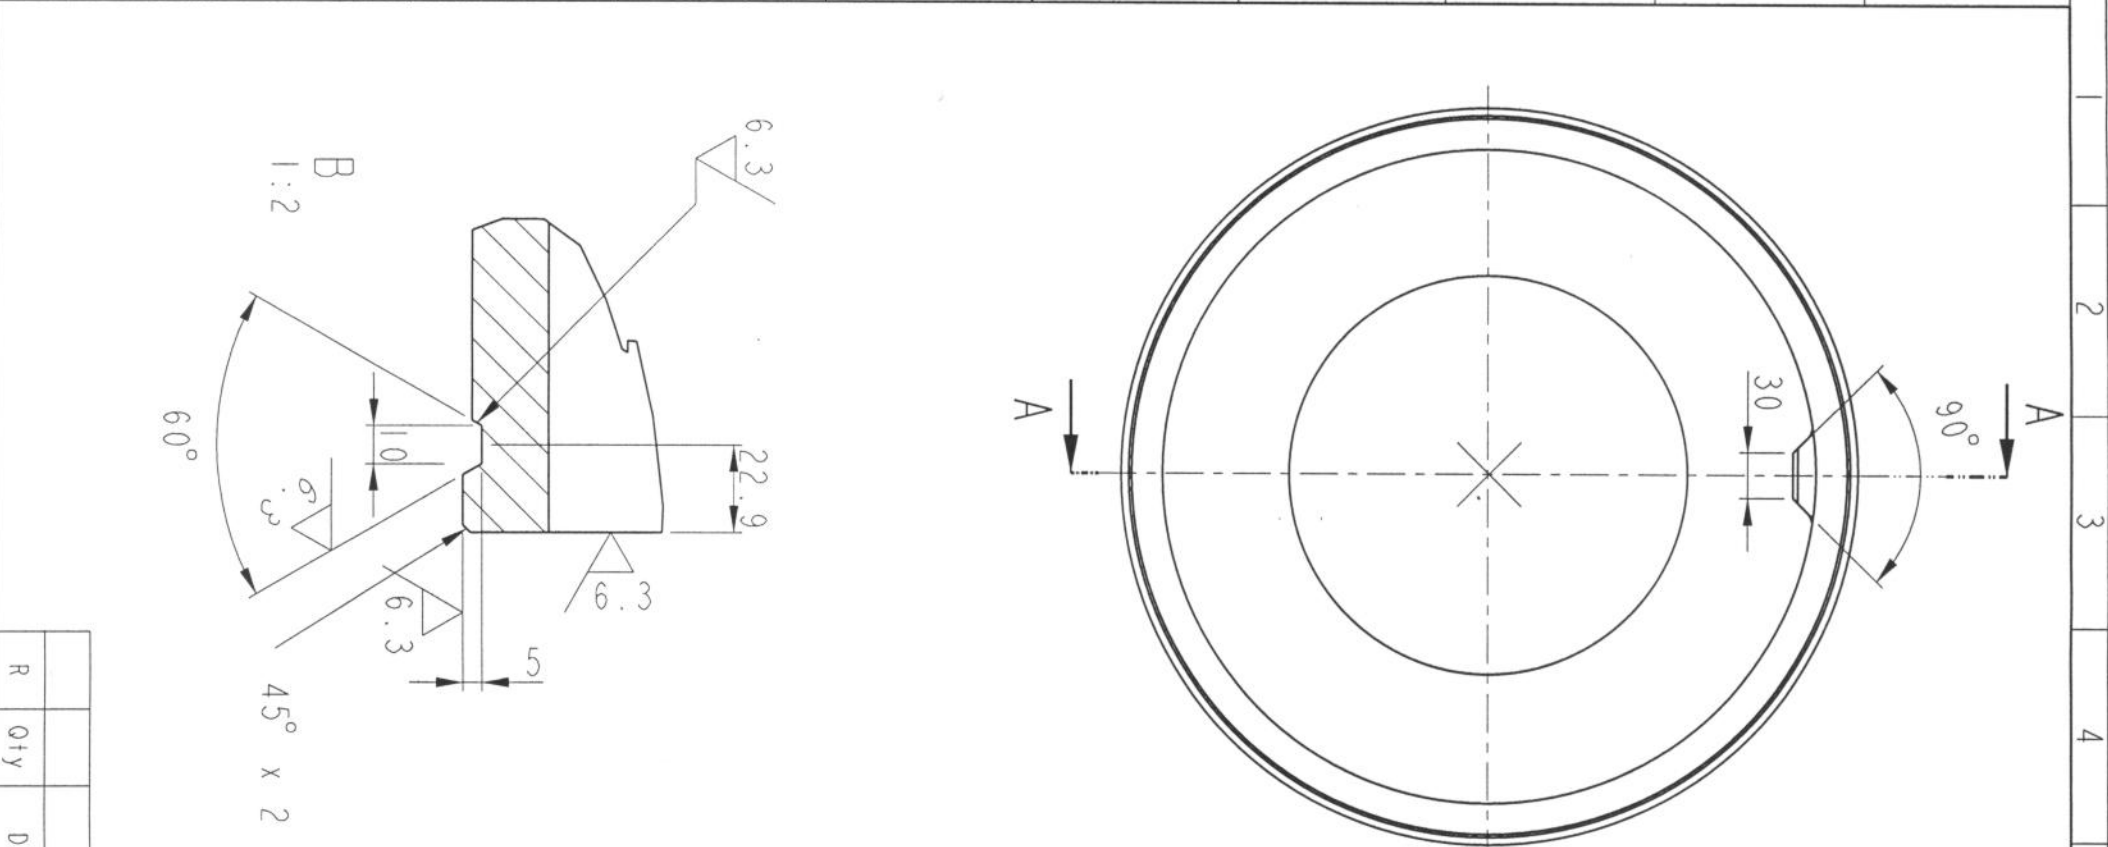


K J H C E F

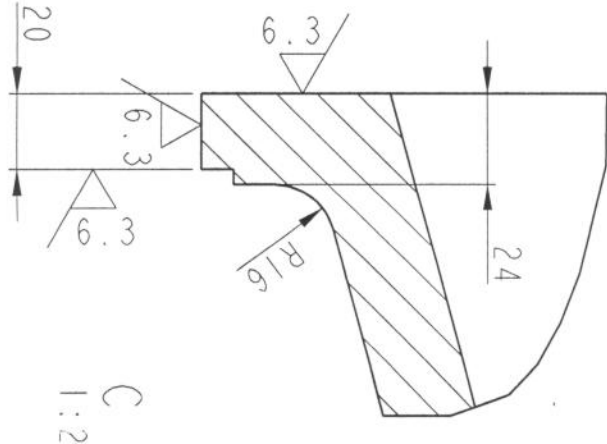

A B C D E F G H

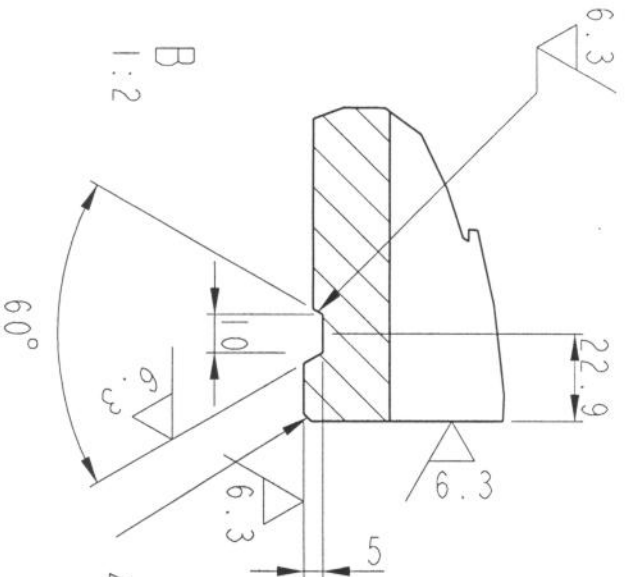

R	Qty	Date	Revision	Design.	Check.	App.

I	PIPE	G-X260Cr27DIN1695	Ø485/262 L=1100	I
Part Item	Material	Drw / Std / Attn:	Qty	
<b>IVO POWER ENGINEERING OY</b>				
EC. SIEKIERKI POWER PLANT BOILER 10				
RI - JET LOW-NOX COAL BURNER				
VENTURI				
Scale: 1:5 Level: APM Size: A3 Sheets: 1 Project - Code no. / File no. / Sheet: SINOX-HHA-030 / 1 Revision: M				
Tolerance: CT10 SFS-ISO 8062 ISO2768-m Weight: 227.6 kg Associate: SINOX-HHA-030				
Checked by: JYL Designer / Date: /21-Oct-97				
Approved by / Date: LPM EUM 1.12.97				
Drawn by: KONSUL / MOJ				