


© This drawing is property of IVO Power Engineering Ltd.
Use and reproduction only by owners permission.

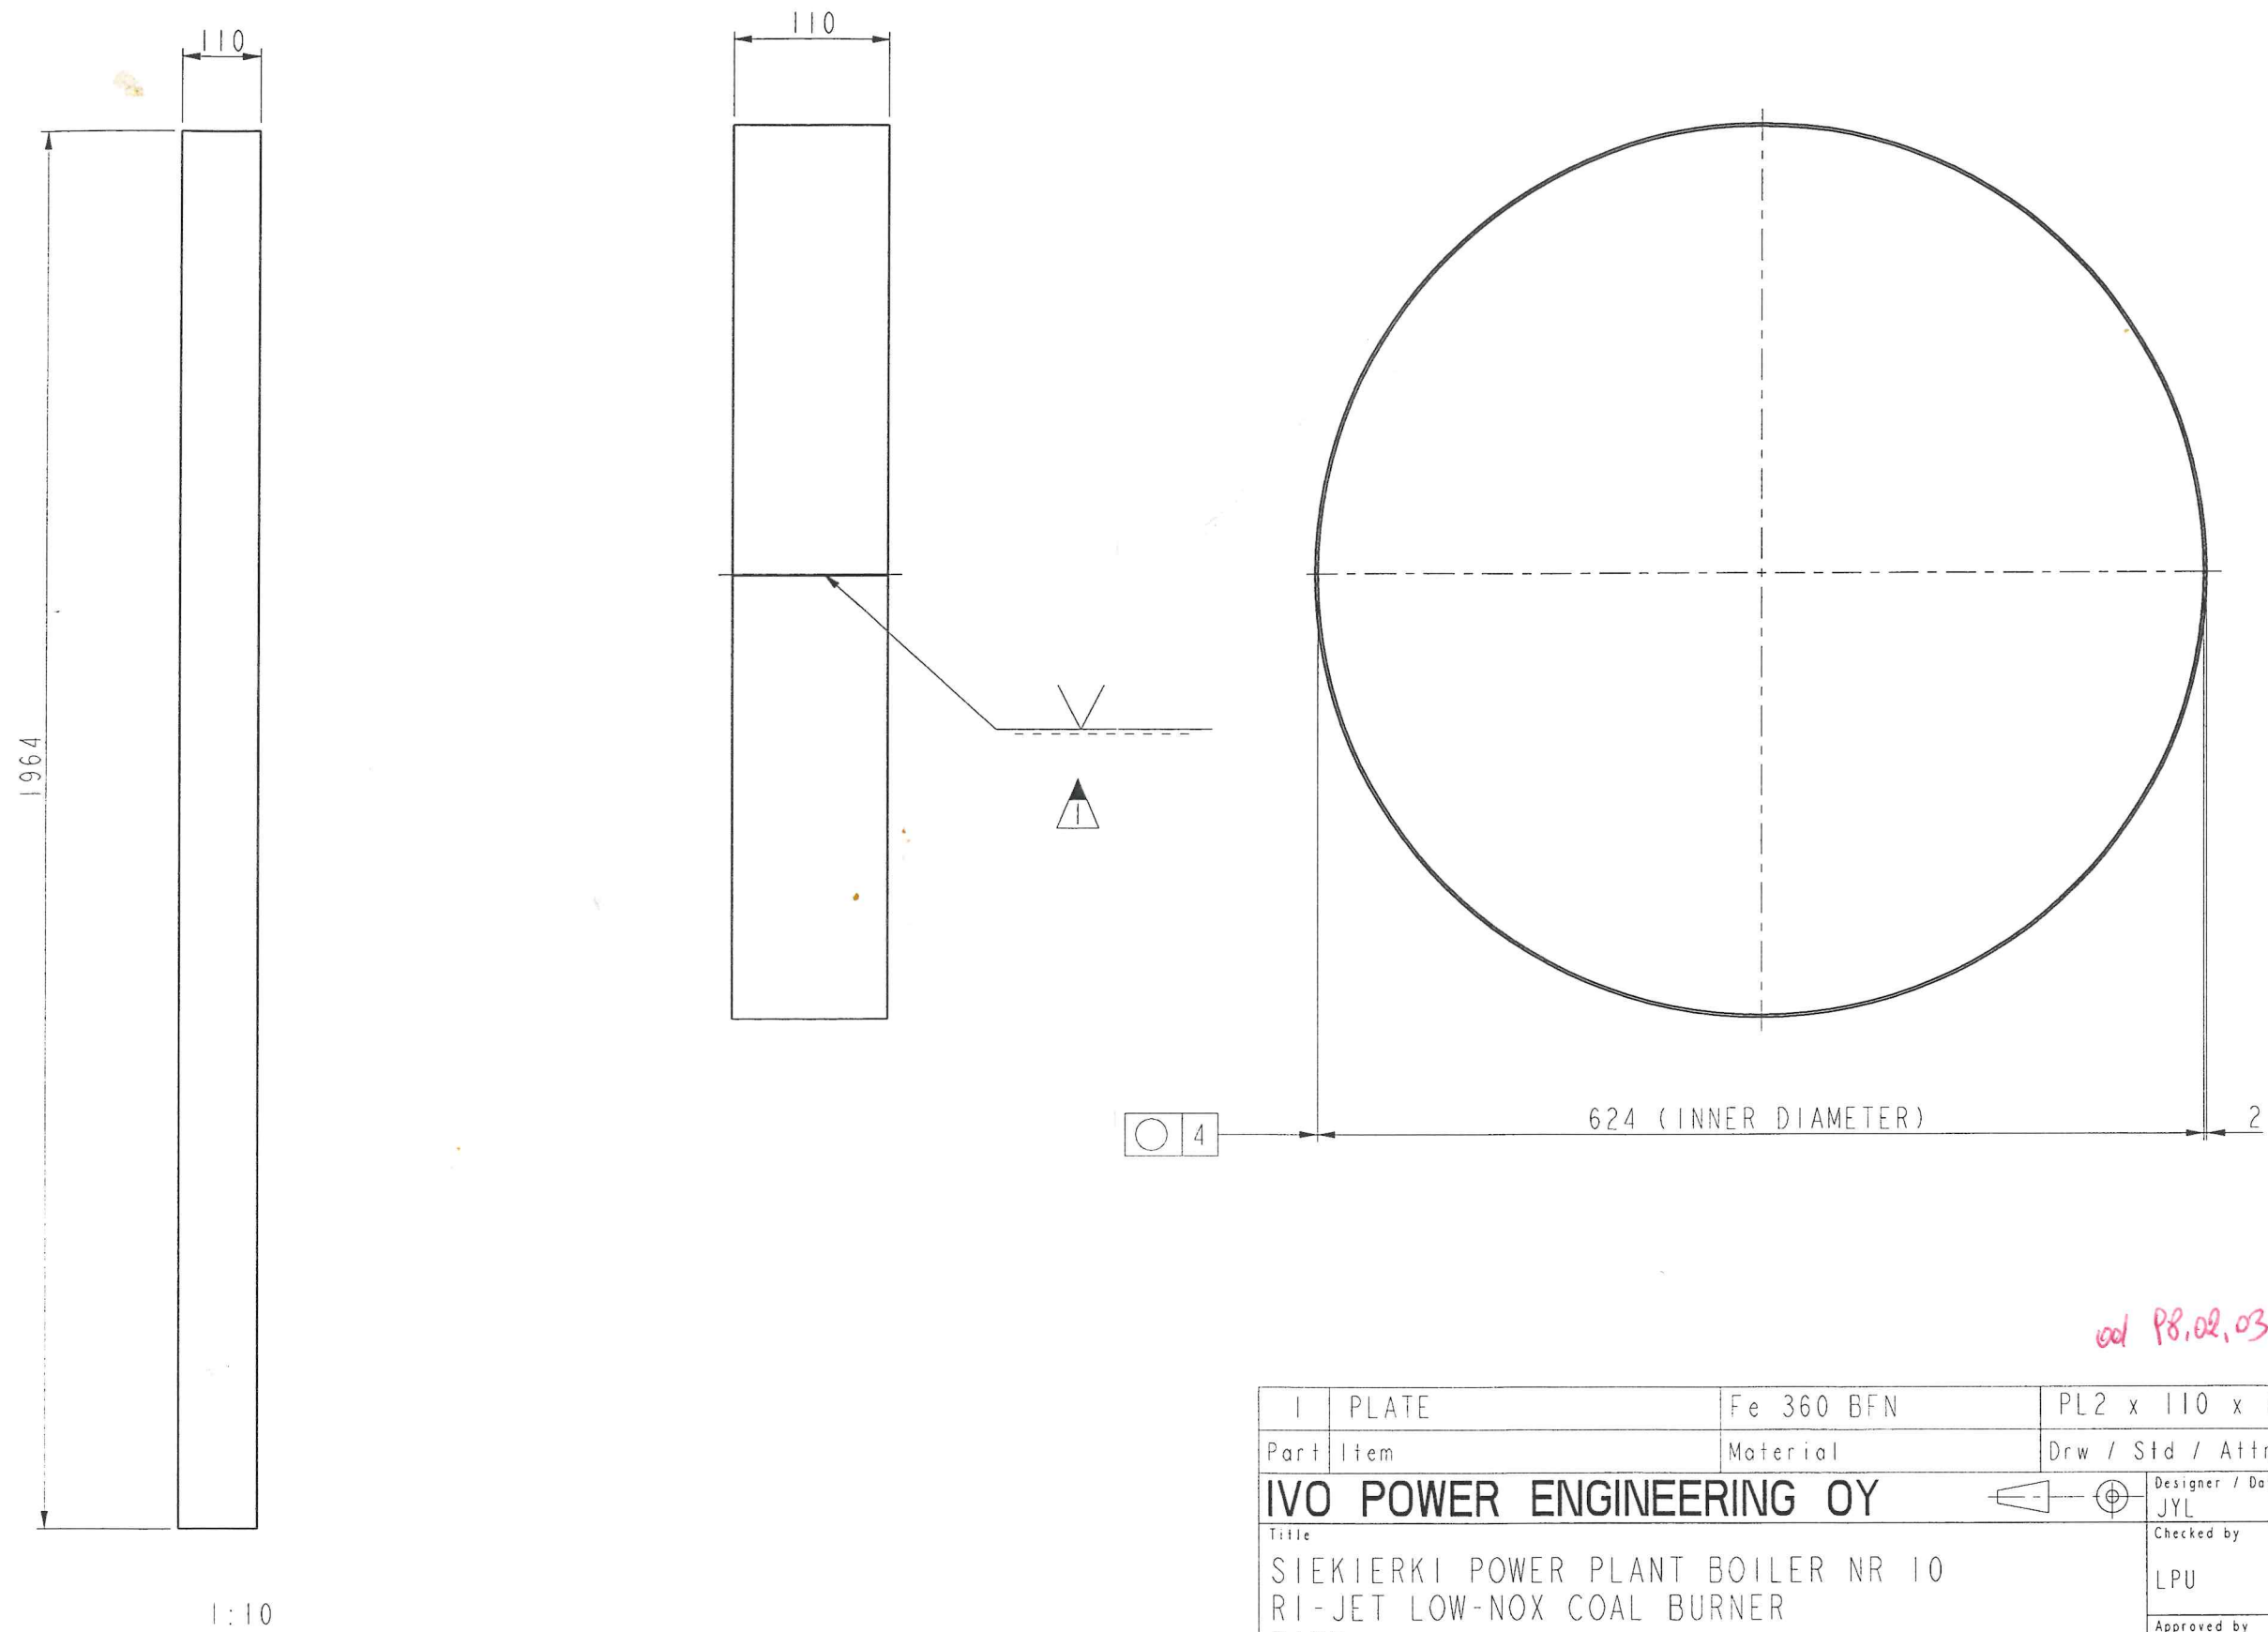

col P8.02.03 *[Signature]*

1	PLATE	Fe 360 BFN	PL2 x 110 x 1964	1
Part	Item	Material	Drw / Std / Attn!	Qty
IVO POWER ENGINEERING OY			Designer / Date	
SIEKIERKI POWER PLANT BOILER NR 10 RI-JET LOW-NOX COAL BURNER PIPE			JYL	/05-Dec-97
			Checked by	Org
			LPU	ENM
			Approved by PHRA 9.11.87	
Drawn by KONSUL/PVI				
Scale	Level	Size	Sheets	Project - Code no. - File no. / Sheet
1:5	AFM	A3	1	SINOX-HHA-057
Tolerance ISO2768-c		Weight 3.4 KG	Associate	Revision MI
Filename SINOX-HHA-057				

I	I	28.1.98	Welding changed	MOJ	LPU	PVR
R	Qty	Date	Revision	Design.	Check.	App.